

Plumbing Fixture Schedule			
Count	Level	Family	Type
Dishwasher			
1	FIRST FL	Dishwasher	26"x24"
Lavatory-Pedestal-TOTO-Whitney-LPT754			
1	TOP FOOTING	Lavatory-Pedestal-TOTO-Whitney-LPT754	01 Cotton
1	FIRST FL	Lavatory-Pedestal-TOTO-Whitney-LPT754	01 Cotton
1	SECOND FL	Lavatory-Pedestal-TOTO-Whitney-LPT754	01 Cotton
M_Washing Machine			
1	TOP FOOTING	M_Washing Machine	660 mmx660 mm - Public
Sink Kitchen-Single			
1	FIRST FL	Sink Kitchen-Single	30" x 21"
Toilet-Domestic-3D			
1	FIRST FL	Toilet-Domestic-3D	Toilet-Domestic-3D
1	SECOND FL	Toilet-Domestic-3D	Toilet-Domestic-3D
Tub-Rectangular-3D			
1	SECOND FL	Tub-Rectangular-3D	Tub-Rectangular-3D
Water Heater			
1	TOP FOOTING	Water Heater	40 Gallon
Grand total: 10			
Pipe Schedule			
Size	Length	System Abbreviation	Material
1"	41' - 10 3/4"	CW	Copper
1": 5	41' - 10 3/4"		
1/2"	56' - 4 1/2"	CW	Copper
1/2"	31' - 4 11/32"	HW	Copper
1/2": 30	87' - 8 7/8"		
3/8"	20' - 9 17/32"	CW	Copper
3/8"	34' - 5 3/16"	HW	Copper
3/8": 31	55' - 2 11/16"		
5/8"	16' - 5 5/8"	CW	Copper
5/8"	15' - 8 1/16"	HW	Copper
5/8": 9	32' - 1 11/16"		
	217' - 0"		

ELBOW



TEE



CAP



 
Fittings

 
1 1/2" = 1'-0"

 
GENERAL NOTES:

 
- 1-INSTALLATION OF PLUMBING PIPING SHALL BE FULLY COORDINATED WITH STRUCTURAL, ARCHITECTURAL,ELECTRICAL, AND HVAC DRAWINGS TO AVOID CONFLICT.
- 2-NO PLUMBING (WATER, DRAINS, VENT, OR GAS PIPING) SHALL BE INSTALLED DIRECTLY ABOVE ANY ELECTRICAL PANELS. COORDINATE WITH OTHER DIVISIONS BEFORE PROCEEDING WITH INSTALLATION.
- 3-ALL PLUMBING WORK SHALL BE IN CONFORMANCE WITH THE OHIO PLUMBING CODE, LATEST EDITION ADOPTED BY THE STATE OF OHIO WITH OHIO AMENDMENTS, MUNICIPAL OR CITY CODES, AND THE AUTHORITY HAVING JURISDICTION

 
Sheet List			
Sheet Name	Sheet Number	Drawn By	Checked By
COVER SHEET	P-000	NAWRAS.H	HAMID.P
BASEMENT PLUMBING PLAN	P-101	NAWRAS.H	HAMID.P
FIRST FL PLUMBING PLAN	P-102	NAWRAS.H	HAMID.P
SECOND PLUMBING PLAN	P-103	NAWRAS.H	HAMID.P
RISER DIG	P-901	NAWRAS.H	HAMID.P

 












LAVATORY DISHWASHER WASHING MACHINE KITCHEN SINK WC WATER HEATER



FIXTURES

1/4" = 1'-0"



VERDUN ADULT &
CAREER CENTRE

MODULE 12

PROJECT ONE

No.	Description	Date

COVER SHEET

Project number

Date

Drawn by

Checked by

Project Number


APRIL-2022

NAWRAS.H


HAMID.P

P-000

Scale As indicated

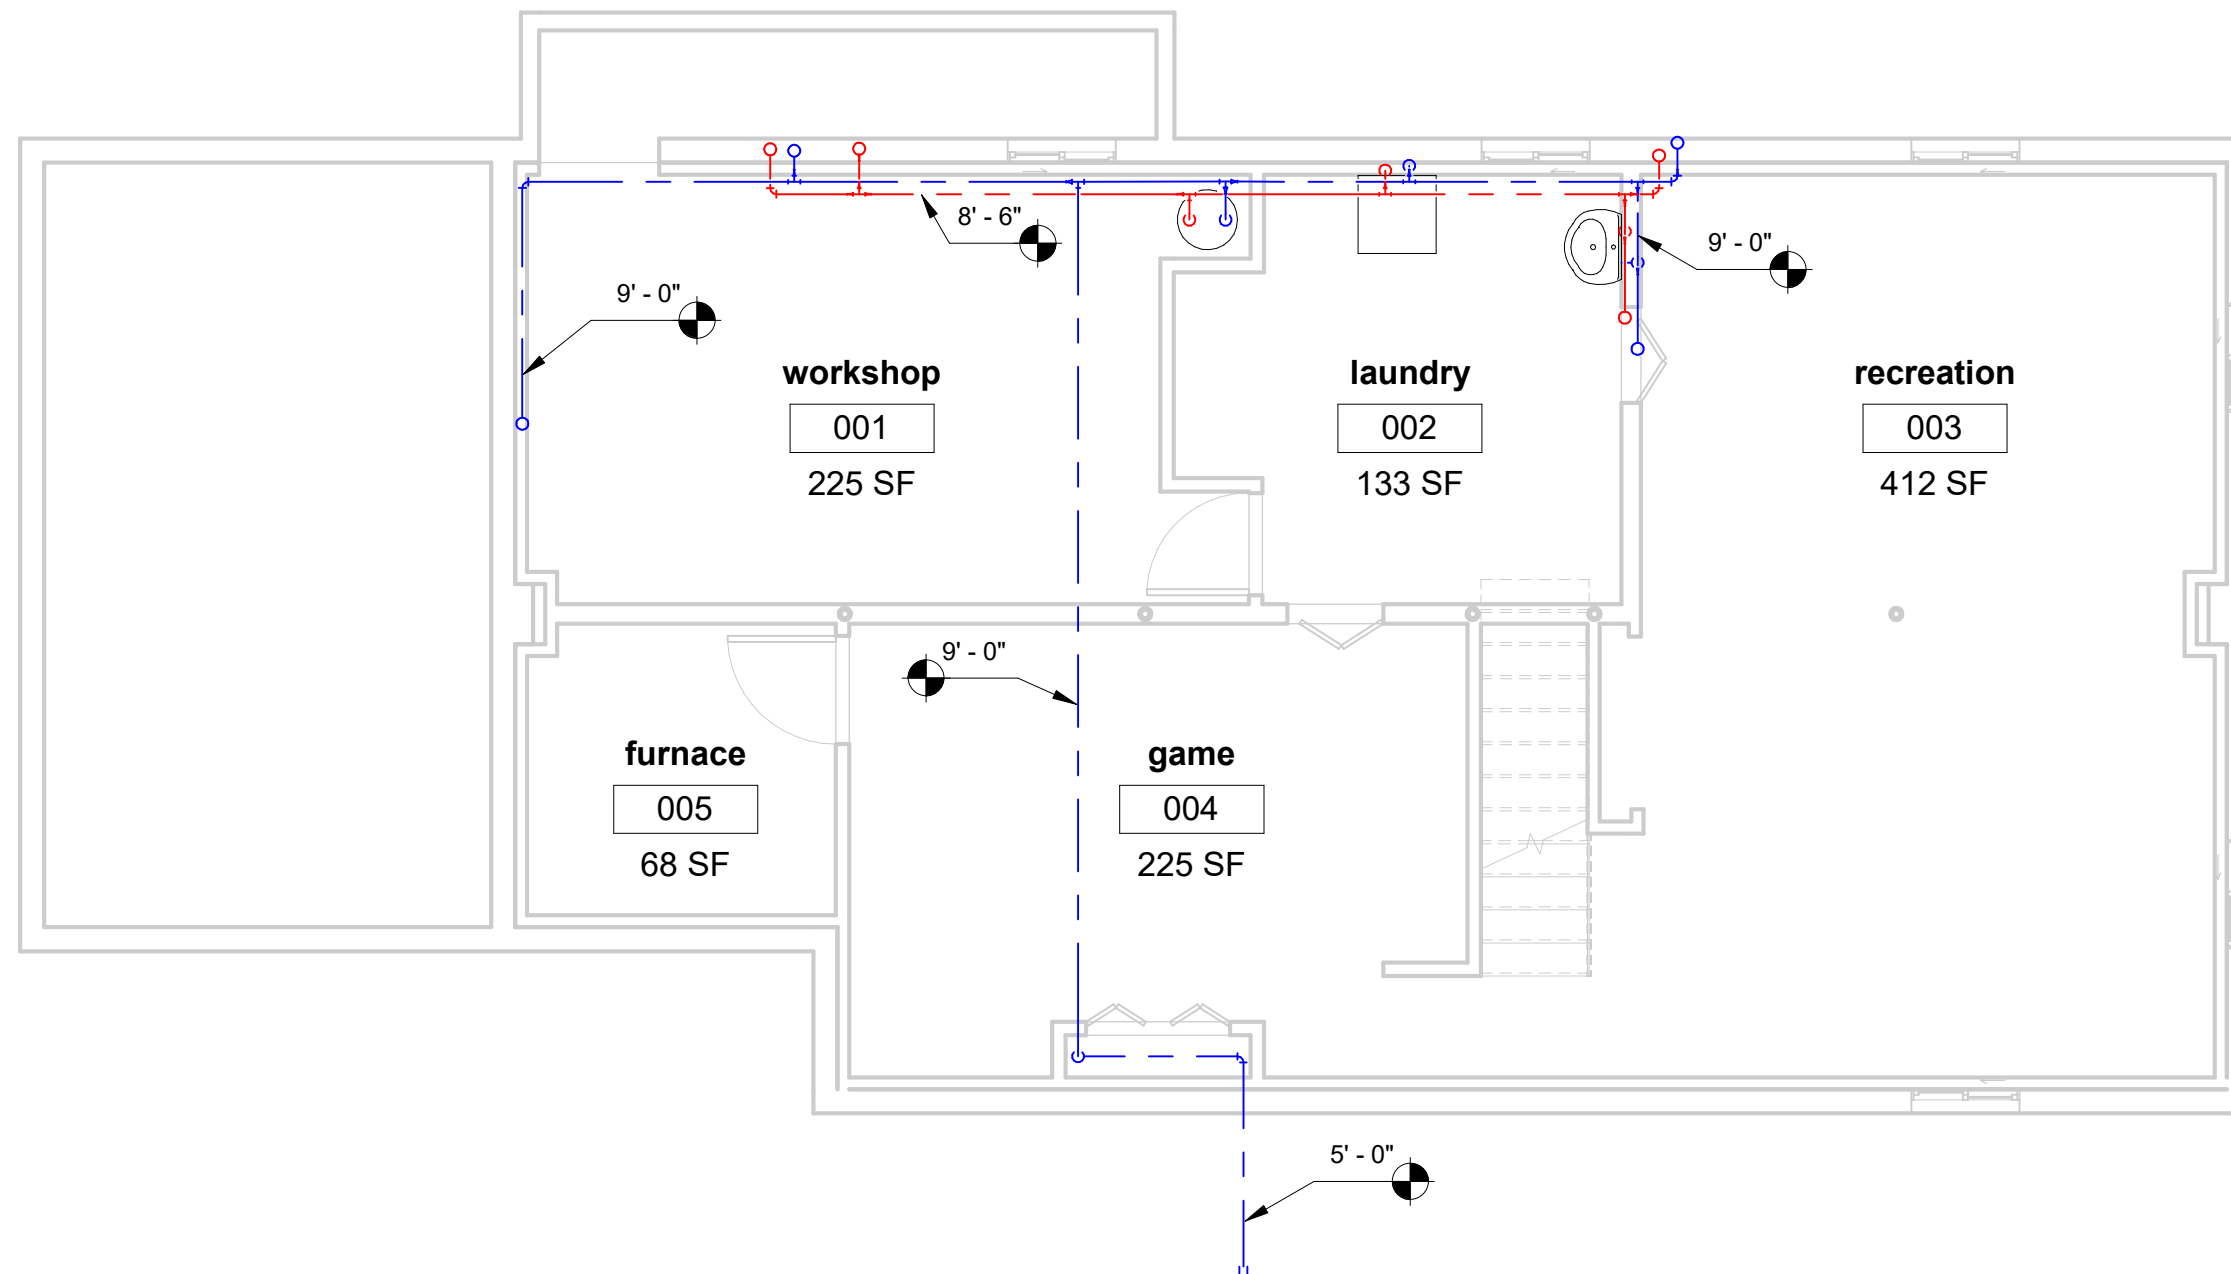

① 01-TOP FOOTING
3/16" = 1'-0"

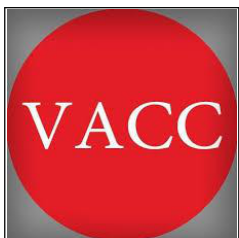


VERDUN ADULT &
CAREER CENTRE

MODULE 12
PROJECT ONE

No.	Description	Date

BASEMENT PLUMBING PLAN		
Project number	Project Number	P-101
Date	APRIL-2022	
Drawn by	NAWRAS.H	
Checked by	HAMID.P	
		Scale 3/16" = 1'-0"

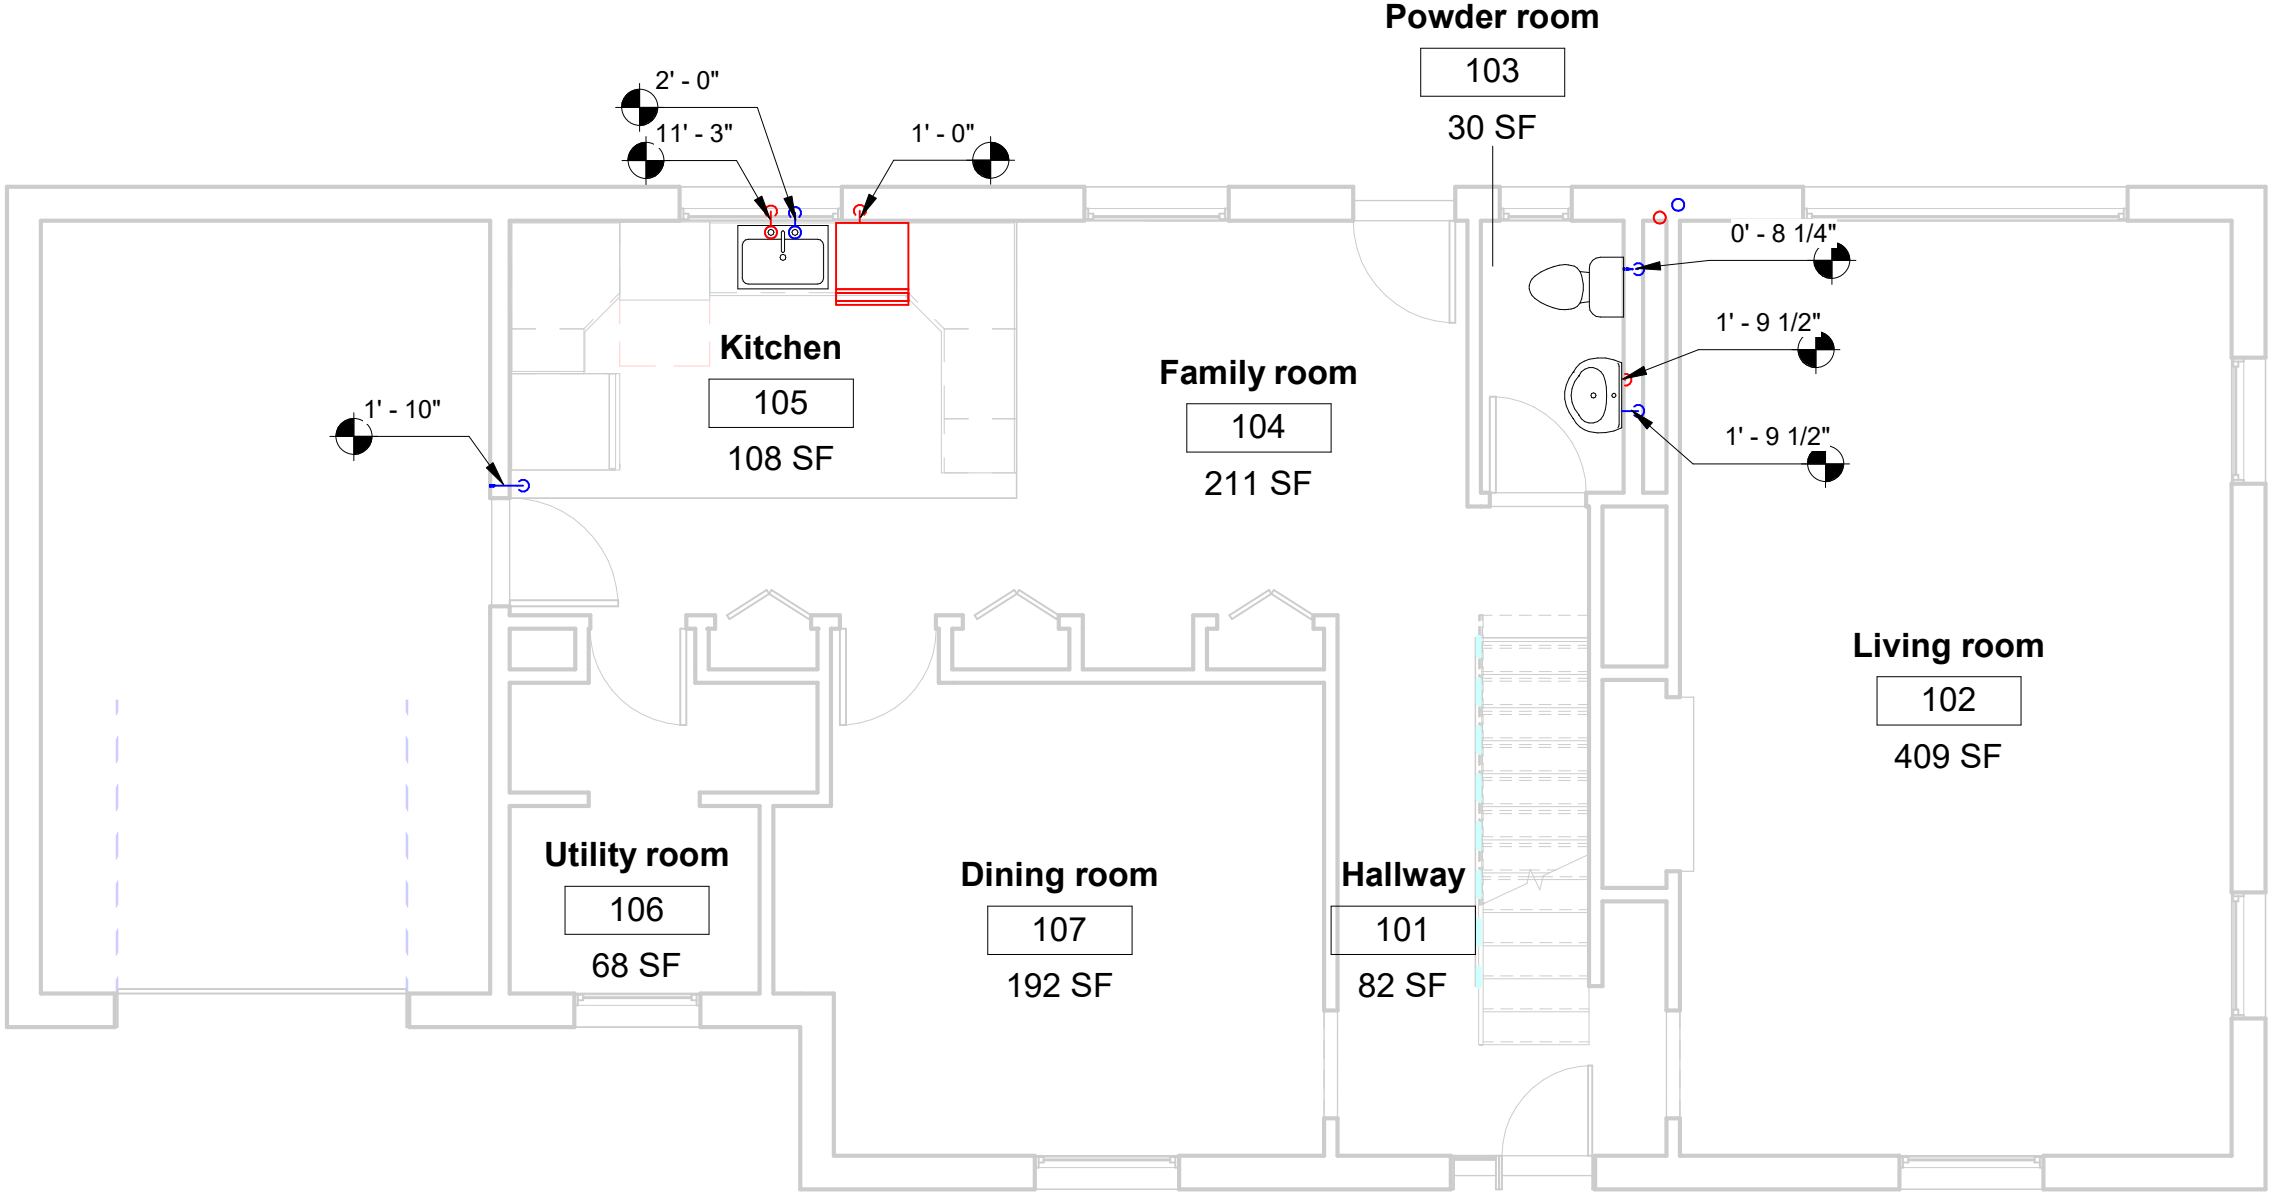

① 02-FIRST FL
3/16" = 1'-0"



VERDUN ADULT &
CAREER CENTRE

MODULE 12 PROJECT ONE


No.	Description	Date

FIRST FL PLUMBING PLAN

Project number	Project Number
Date	APRIL-2022
Drawn by	NAWRAS.H
Checked by	HAMID.P

P-102

Scale 3/16" = 1'-0"

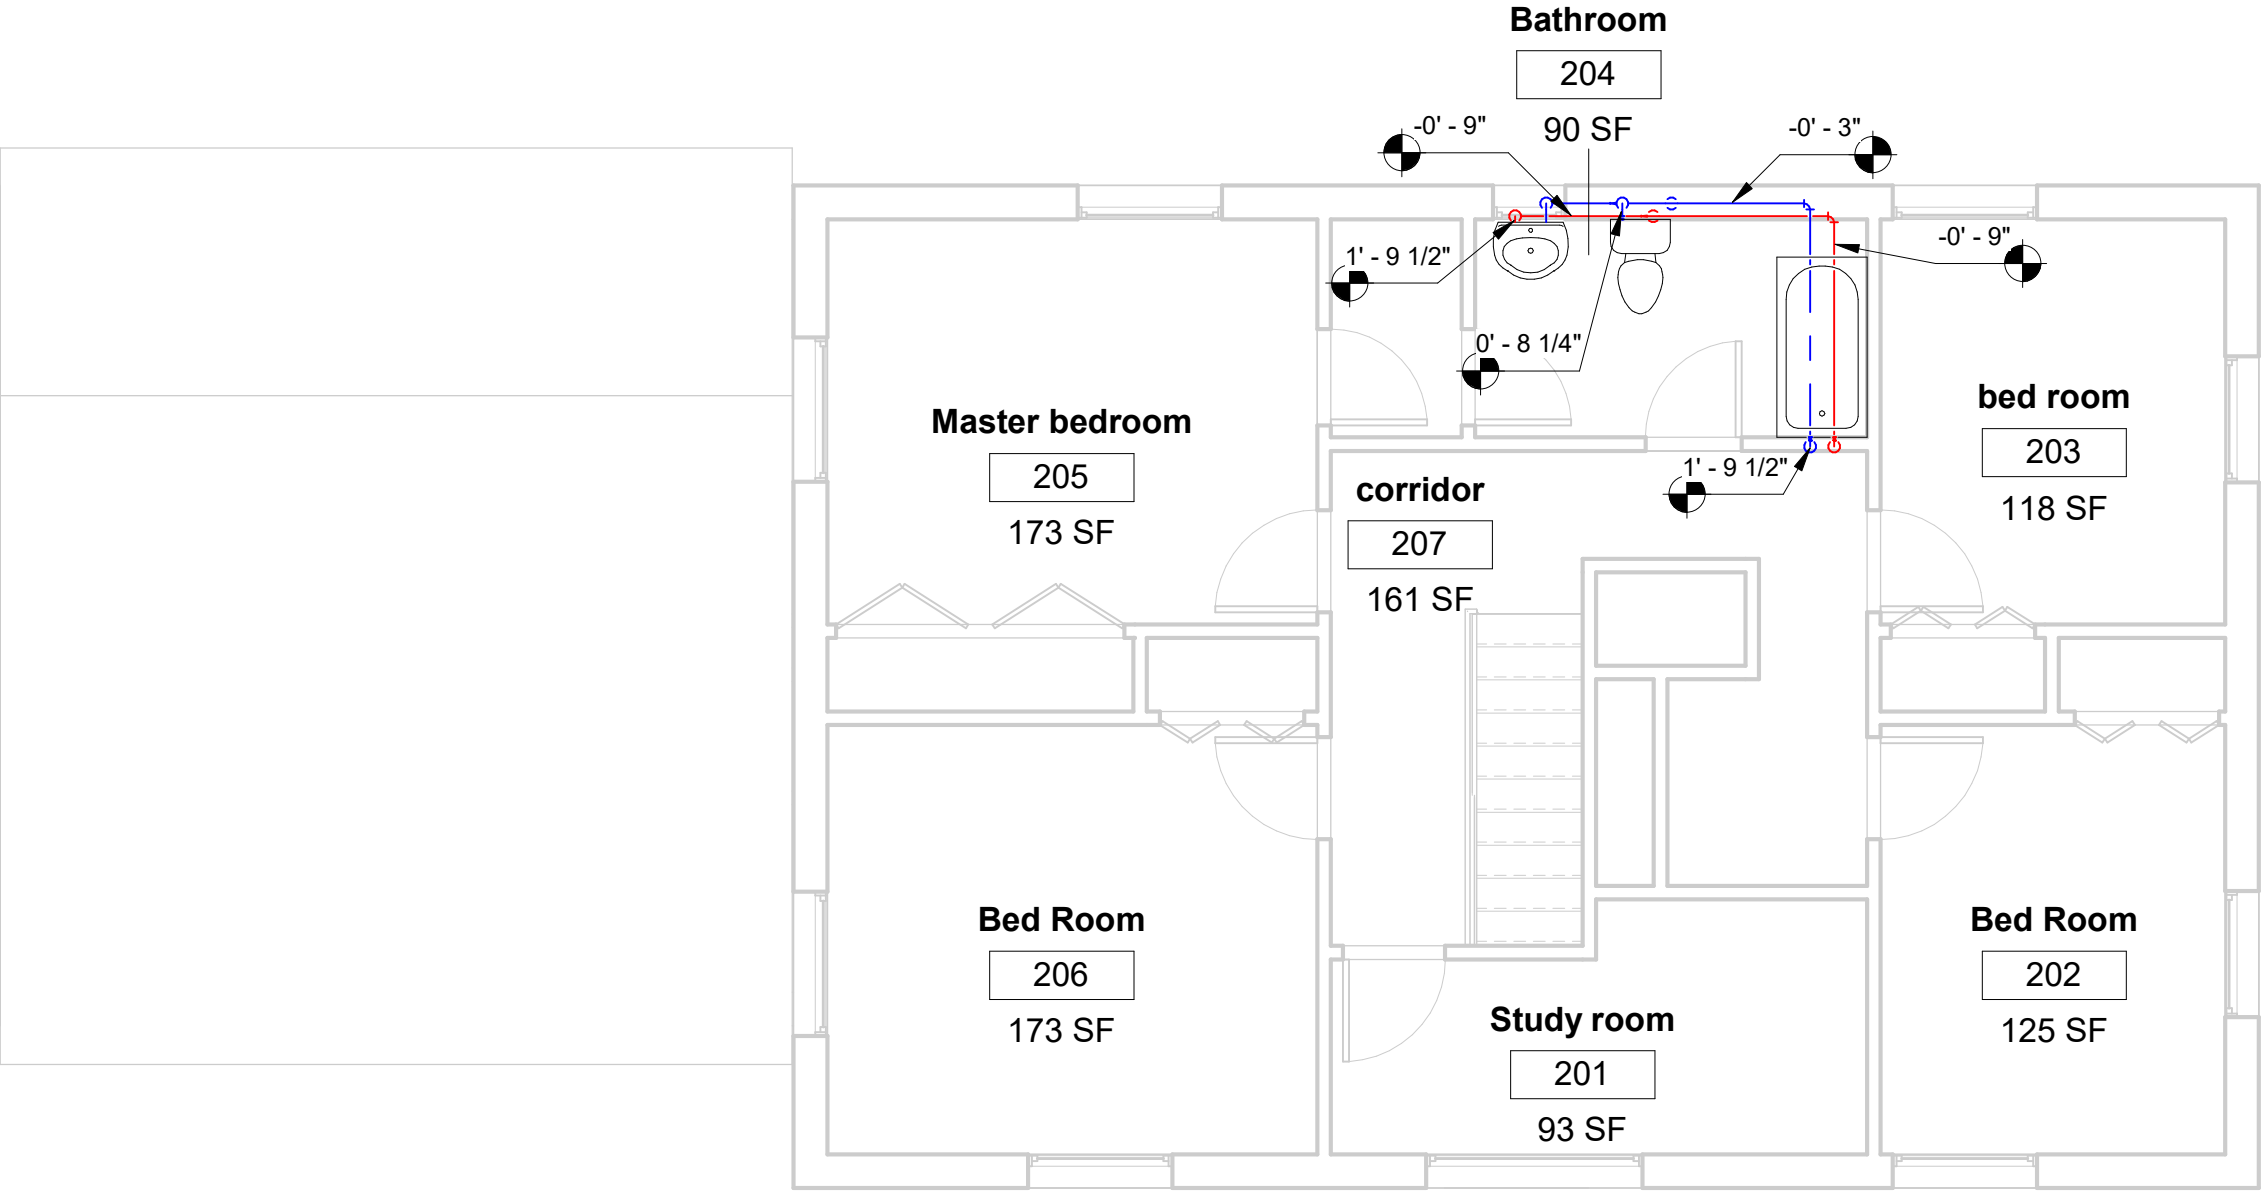

① 03-SECOND FL
3/16" = 1'-0"




VERDUN ADULT &
CAREER CENTRE

MODULE 12
PROJECT ONE

No.	Description	Date

SECOND PLUMBING PLAN		
Project number	Project Number	P-103
Date	APRIL-2022	
Drawn by	NAWRAS.H	
Checked by	HAMID.P	
		Scale 3/16" = 1'-0"

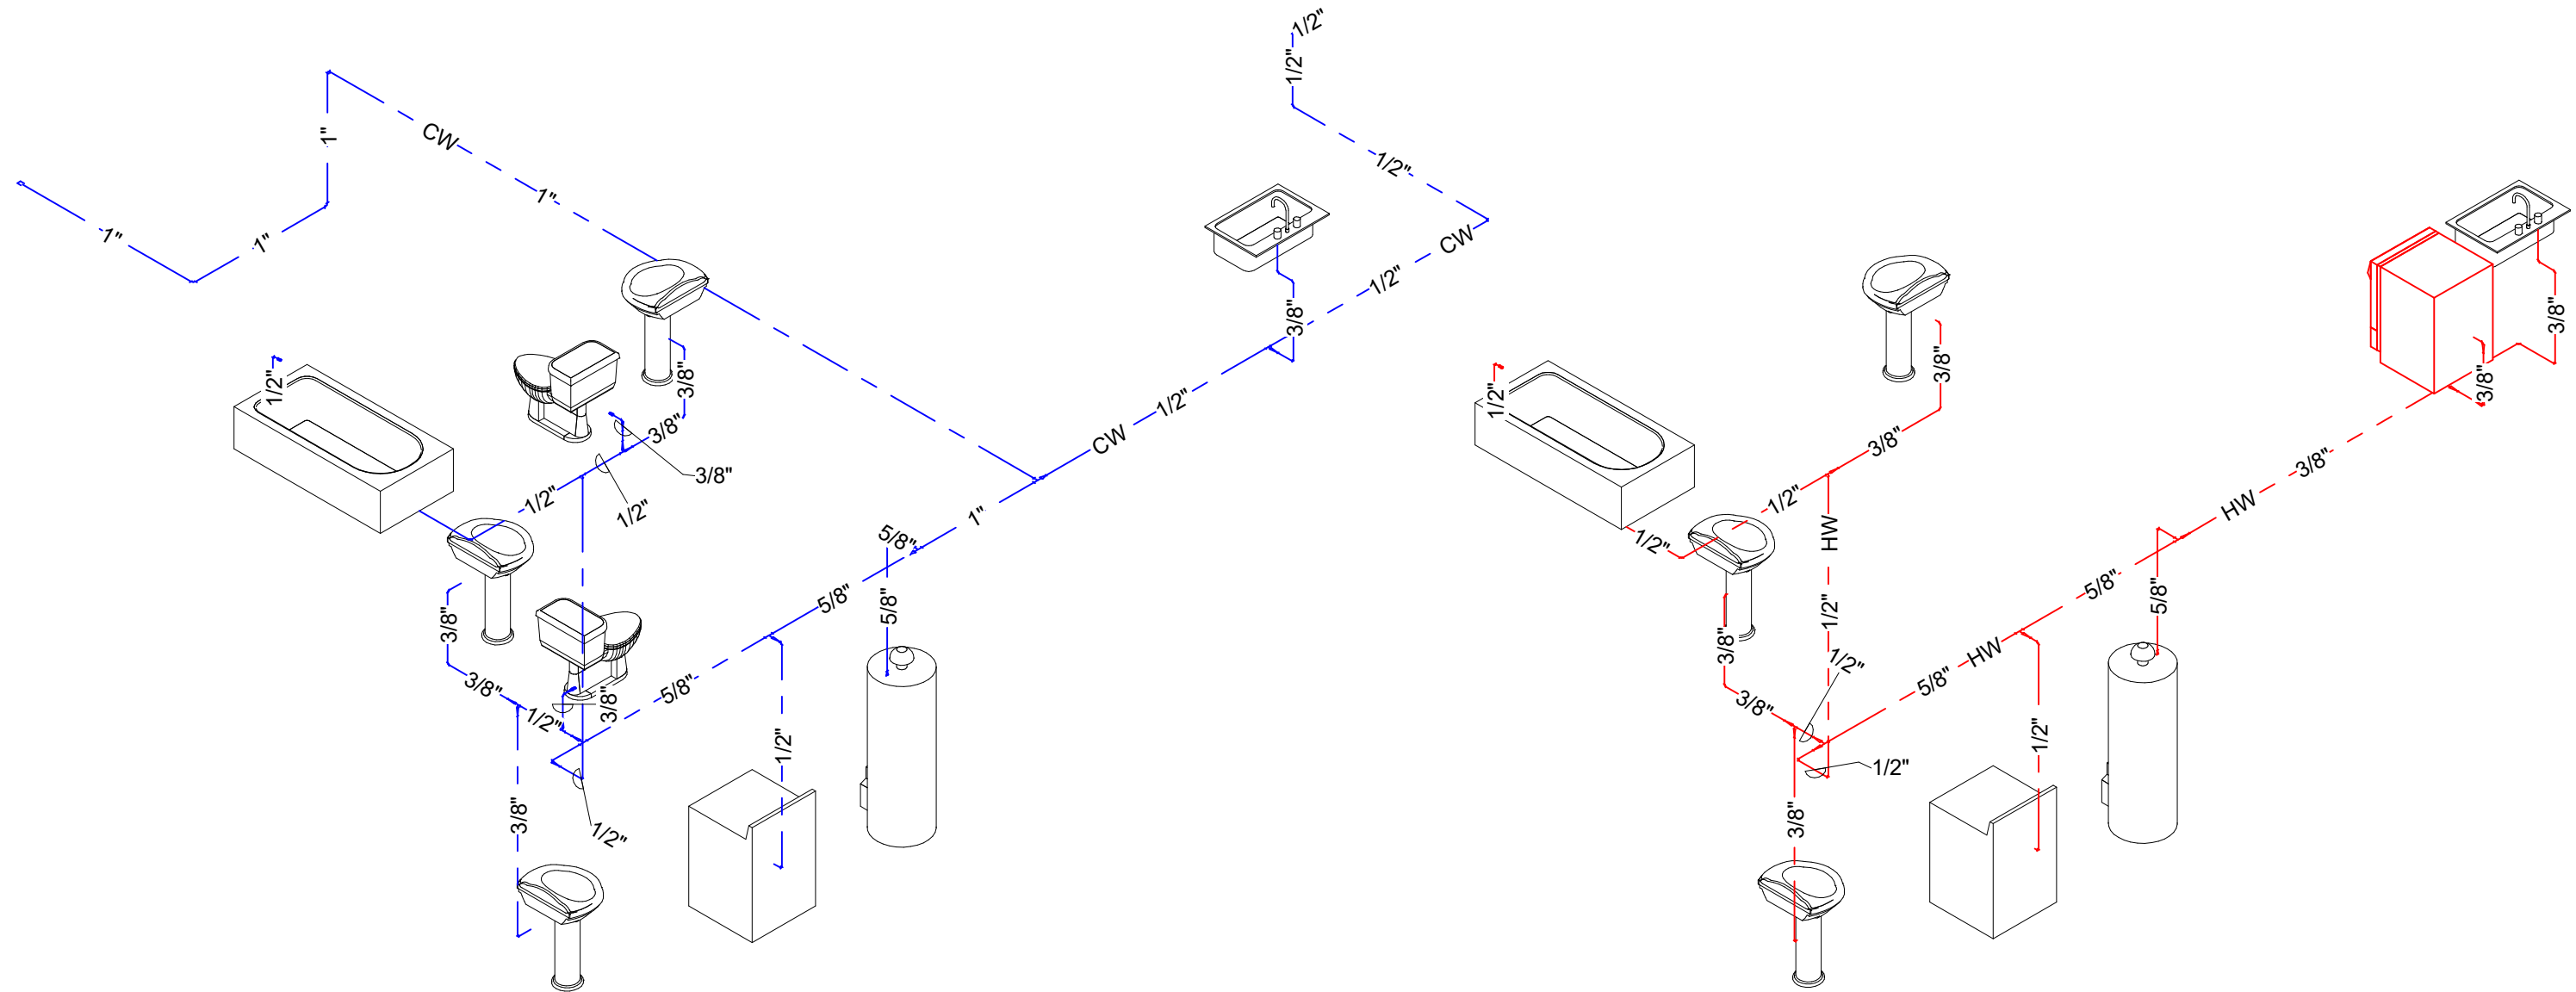

1 Cold Riser Dig

2 Hot Riser Dig



VERDUN ADULT &
CAREER CENTRE

MODULE 12 PROJECT ONE

No.	Description	Date

RISER DIG		
Project number	Project Number	P-901
Date	APRIL-2022	
Drawn by	NAWRAS.H	
Checked by	HAMID.P	
		Scale