


GENERAL NOTES, PANELBOARD AND LEGEND	E-001
BASEMENT FLOOR ELECTRICAL PLAN	E-101
FIRST FLOOR ELECTRICAL PLAN	E-102

	240V OUTLET		CEILING LIGHT FIXTURE		LIGHT SWITCH
	120V GFCI OUTLET		TV JACK		3 WAY LIGHT SWITCH
	120V OUTLET		LIGHT, HEATER AND FAN		4 WAY LIGHT SWITCH
	CAN LIGHT FIXTURE		JUNCTION BOX		FLUORESCENT LIGHT FIXTURE
	WALL LIGHT FIXTURE		SMOKE DETECTOR		CEILING FAN


1. ALL GARAGE AND EXTERIOR PLUGS AND LIGHT FIXTURES TO BE ON GFCI CIRCUIT.
2. ALL KITCHEN PLUGS AND LIGHT FIXTURES TO BE ON GFCI CIRCUIT.
3. ALL LAUNDRY PLUGS AND LIGHT FIXTURES TO BE ON GFCI CIRCUIT.
4. PROVIDE A SEPARATE CIRCUIT FOR MICROWAVE OVEN.
5. VERIFY ALL ELECTRICAL LOCATIONS WITH OWNER.
6. ALL RECESSED LIGHTS IN EXTERIOR TO BE INSULATION COVER RATED.
7. ALL OUTLETS IN BUILDING ARE AT 15" FROM FLOOR UNLESS OTHERWISE INDICATED.
8. ALL KITCHEN OUTLETS ARE AT 54" FROM FLOOR UNLESS OTHERWISE INDICATED.
9. ALL SWITCHES IN BUILDING ARE AT 5' FROM FLOOR UNLESS OTHERWISE INDICATED.
10. ALL SWITCHES THAT ARE LOCATED AT A DOOR WILL BE AT 6" FROM THE OPENING.

[illegible]

AUTODESK	OWNER VACC Verdun Adult and Career Centre	PROJECT RESIDENTIAL ELECTRICAL LAYOUT RESIDENTIAL AND COMMERCIAL DRAFTING-MODULE 04	REV.# #1	DRAWN BY NAWRAS	DATE 2022-09-07	DRAWING NAME GENERAL NOTES- PB-LEGEND	E-001
			REV.DATE 2022-09-07	VERIFIED BY NIGEL	DRAWING SCALE 1/4"=1'-0"	FILE NAME M19 A04 NAWRAS.dwg	

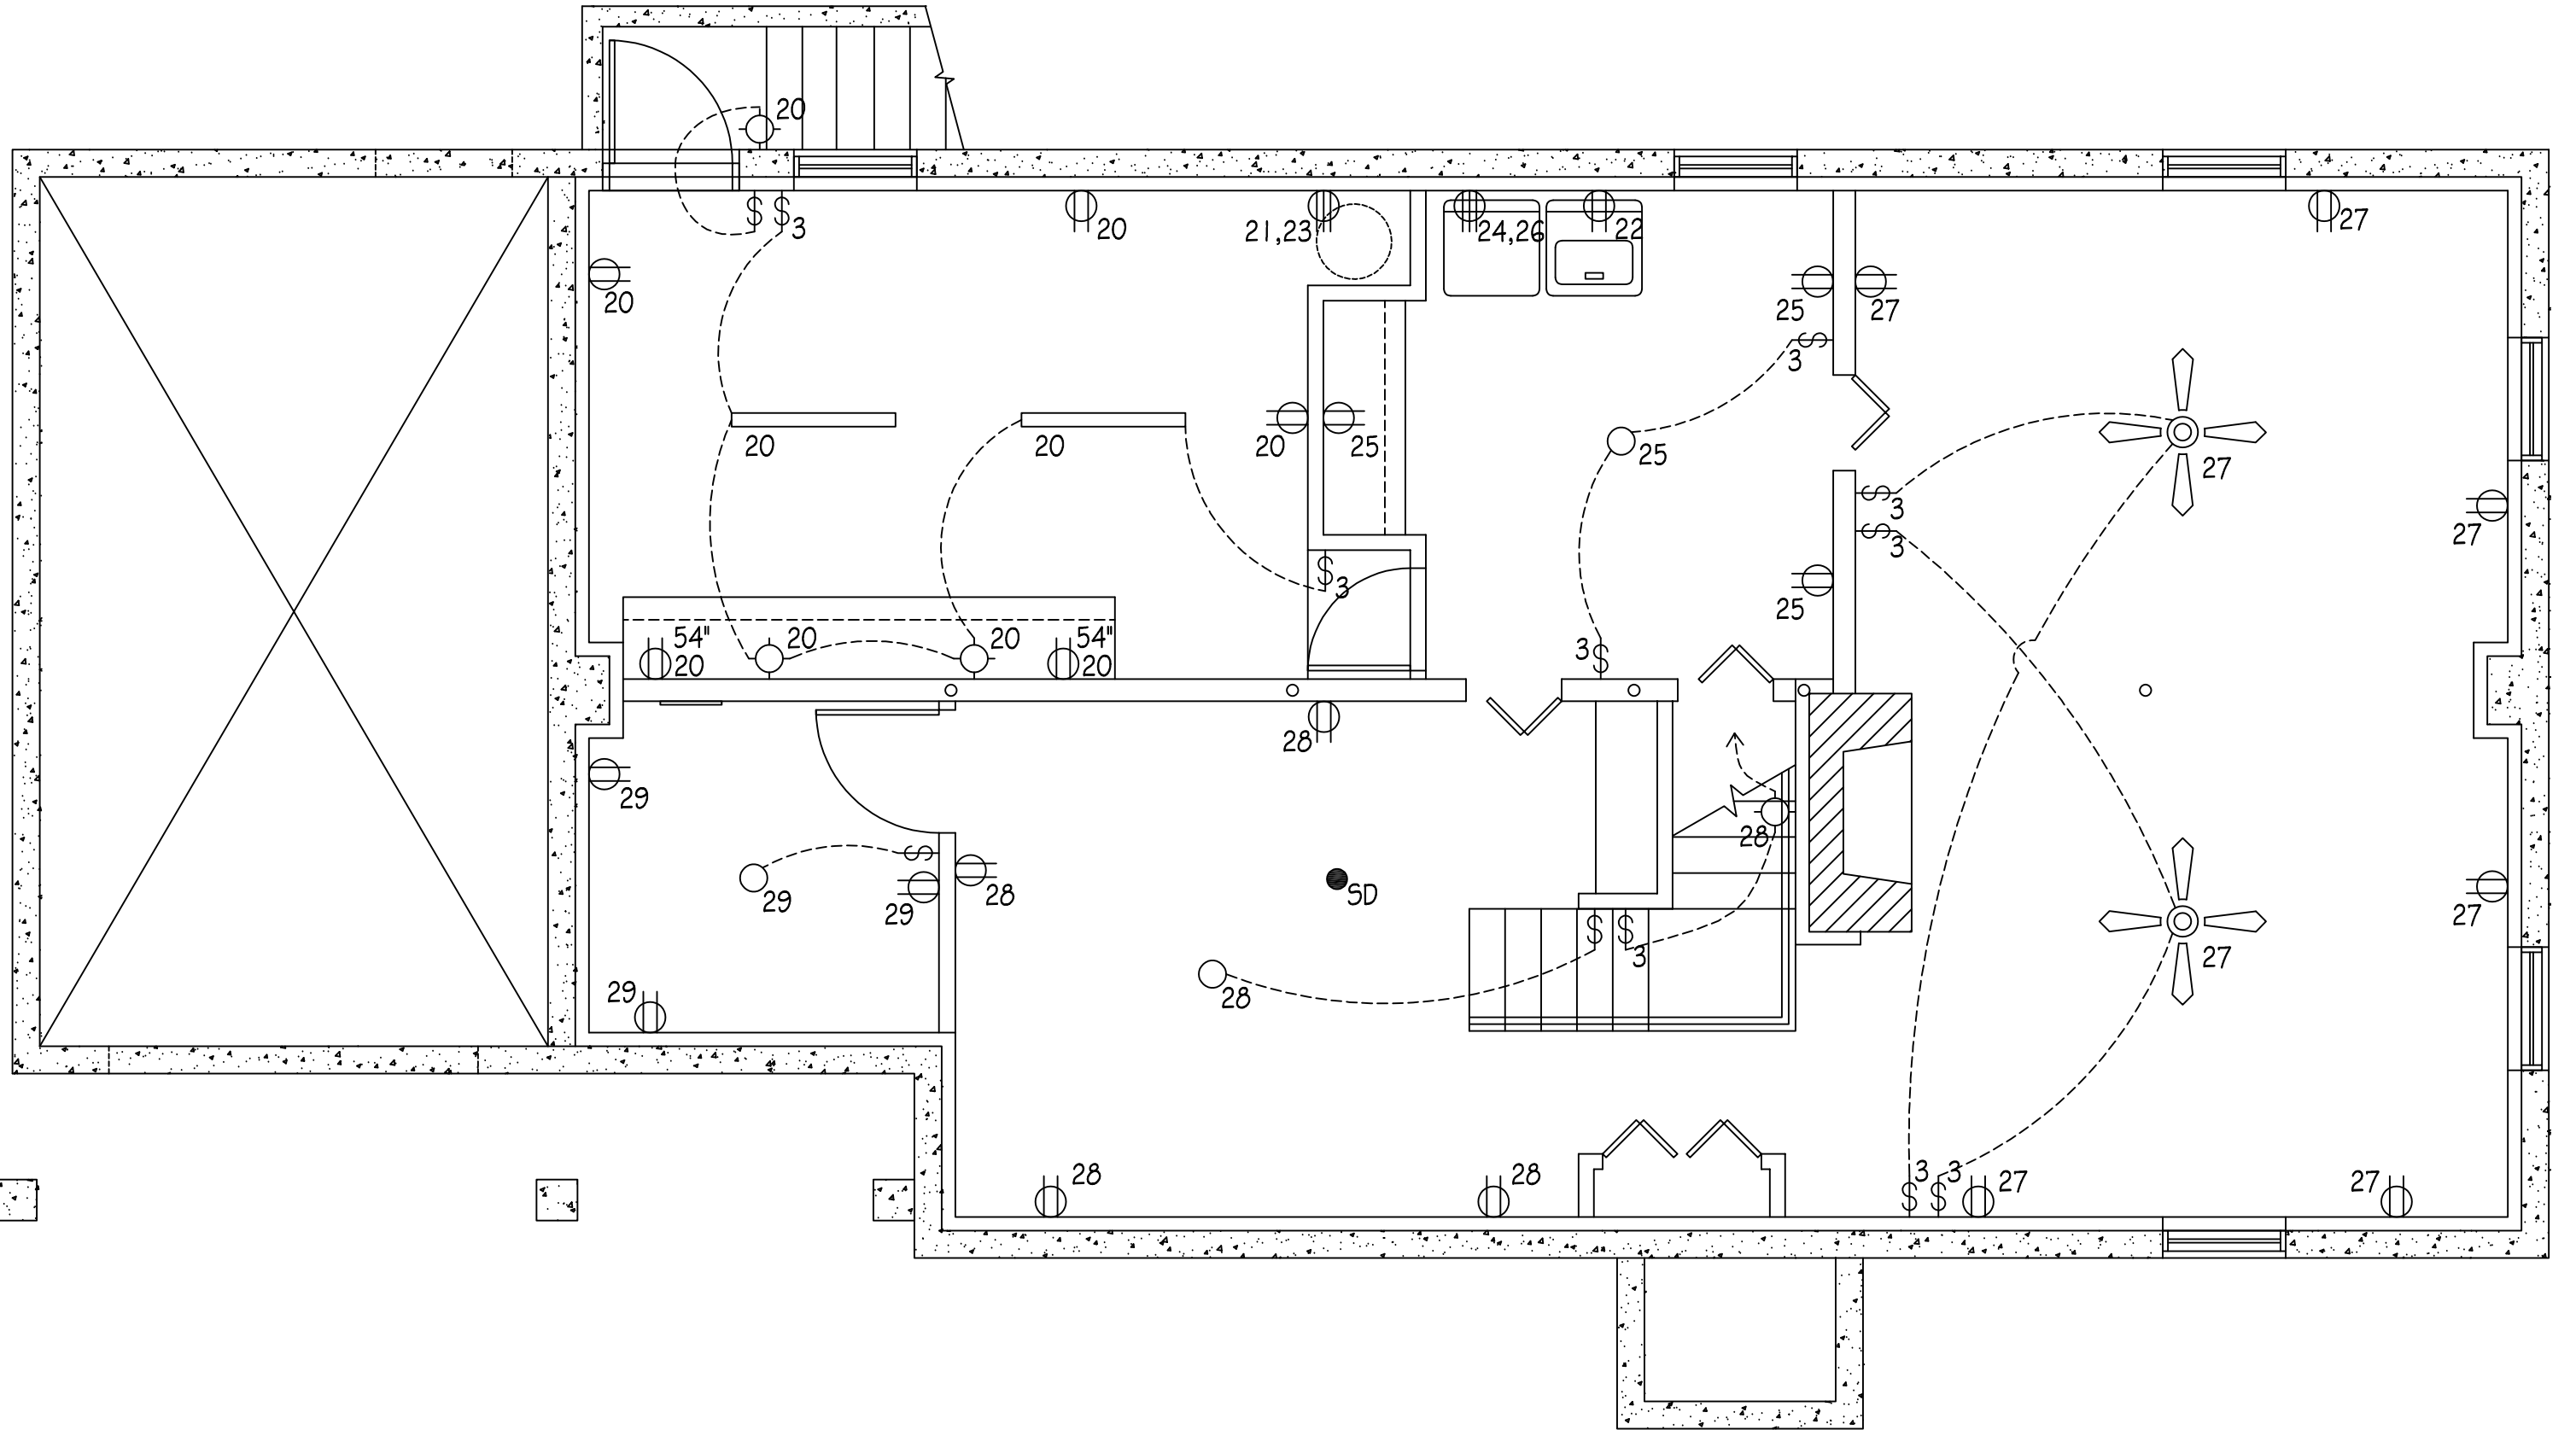

AUTODESK	OWNER VACC Verdun Adult and Career Centre	PROJECT RESIDENTIAL ELECTRICAL LAYOUT RESIDENTIAL AND COMMERCIAL DRAFTING-MODULE 04	REV.# #1	DRAWN BY NAWRAS	DATE 2022-09-07	DRAWING NAME E-BASEMENT FLOOR PLAN	E-101
			REV.DATE 2022-09-07	VERIFIED BY NIGEL	DRAWING SCALE 1/4"=1'-0"	FILE NAME M19_A04_NAWRAS.dwg	

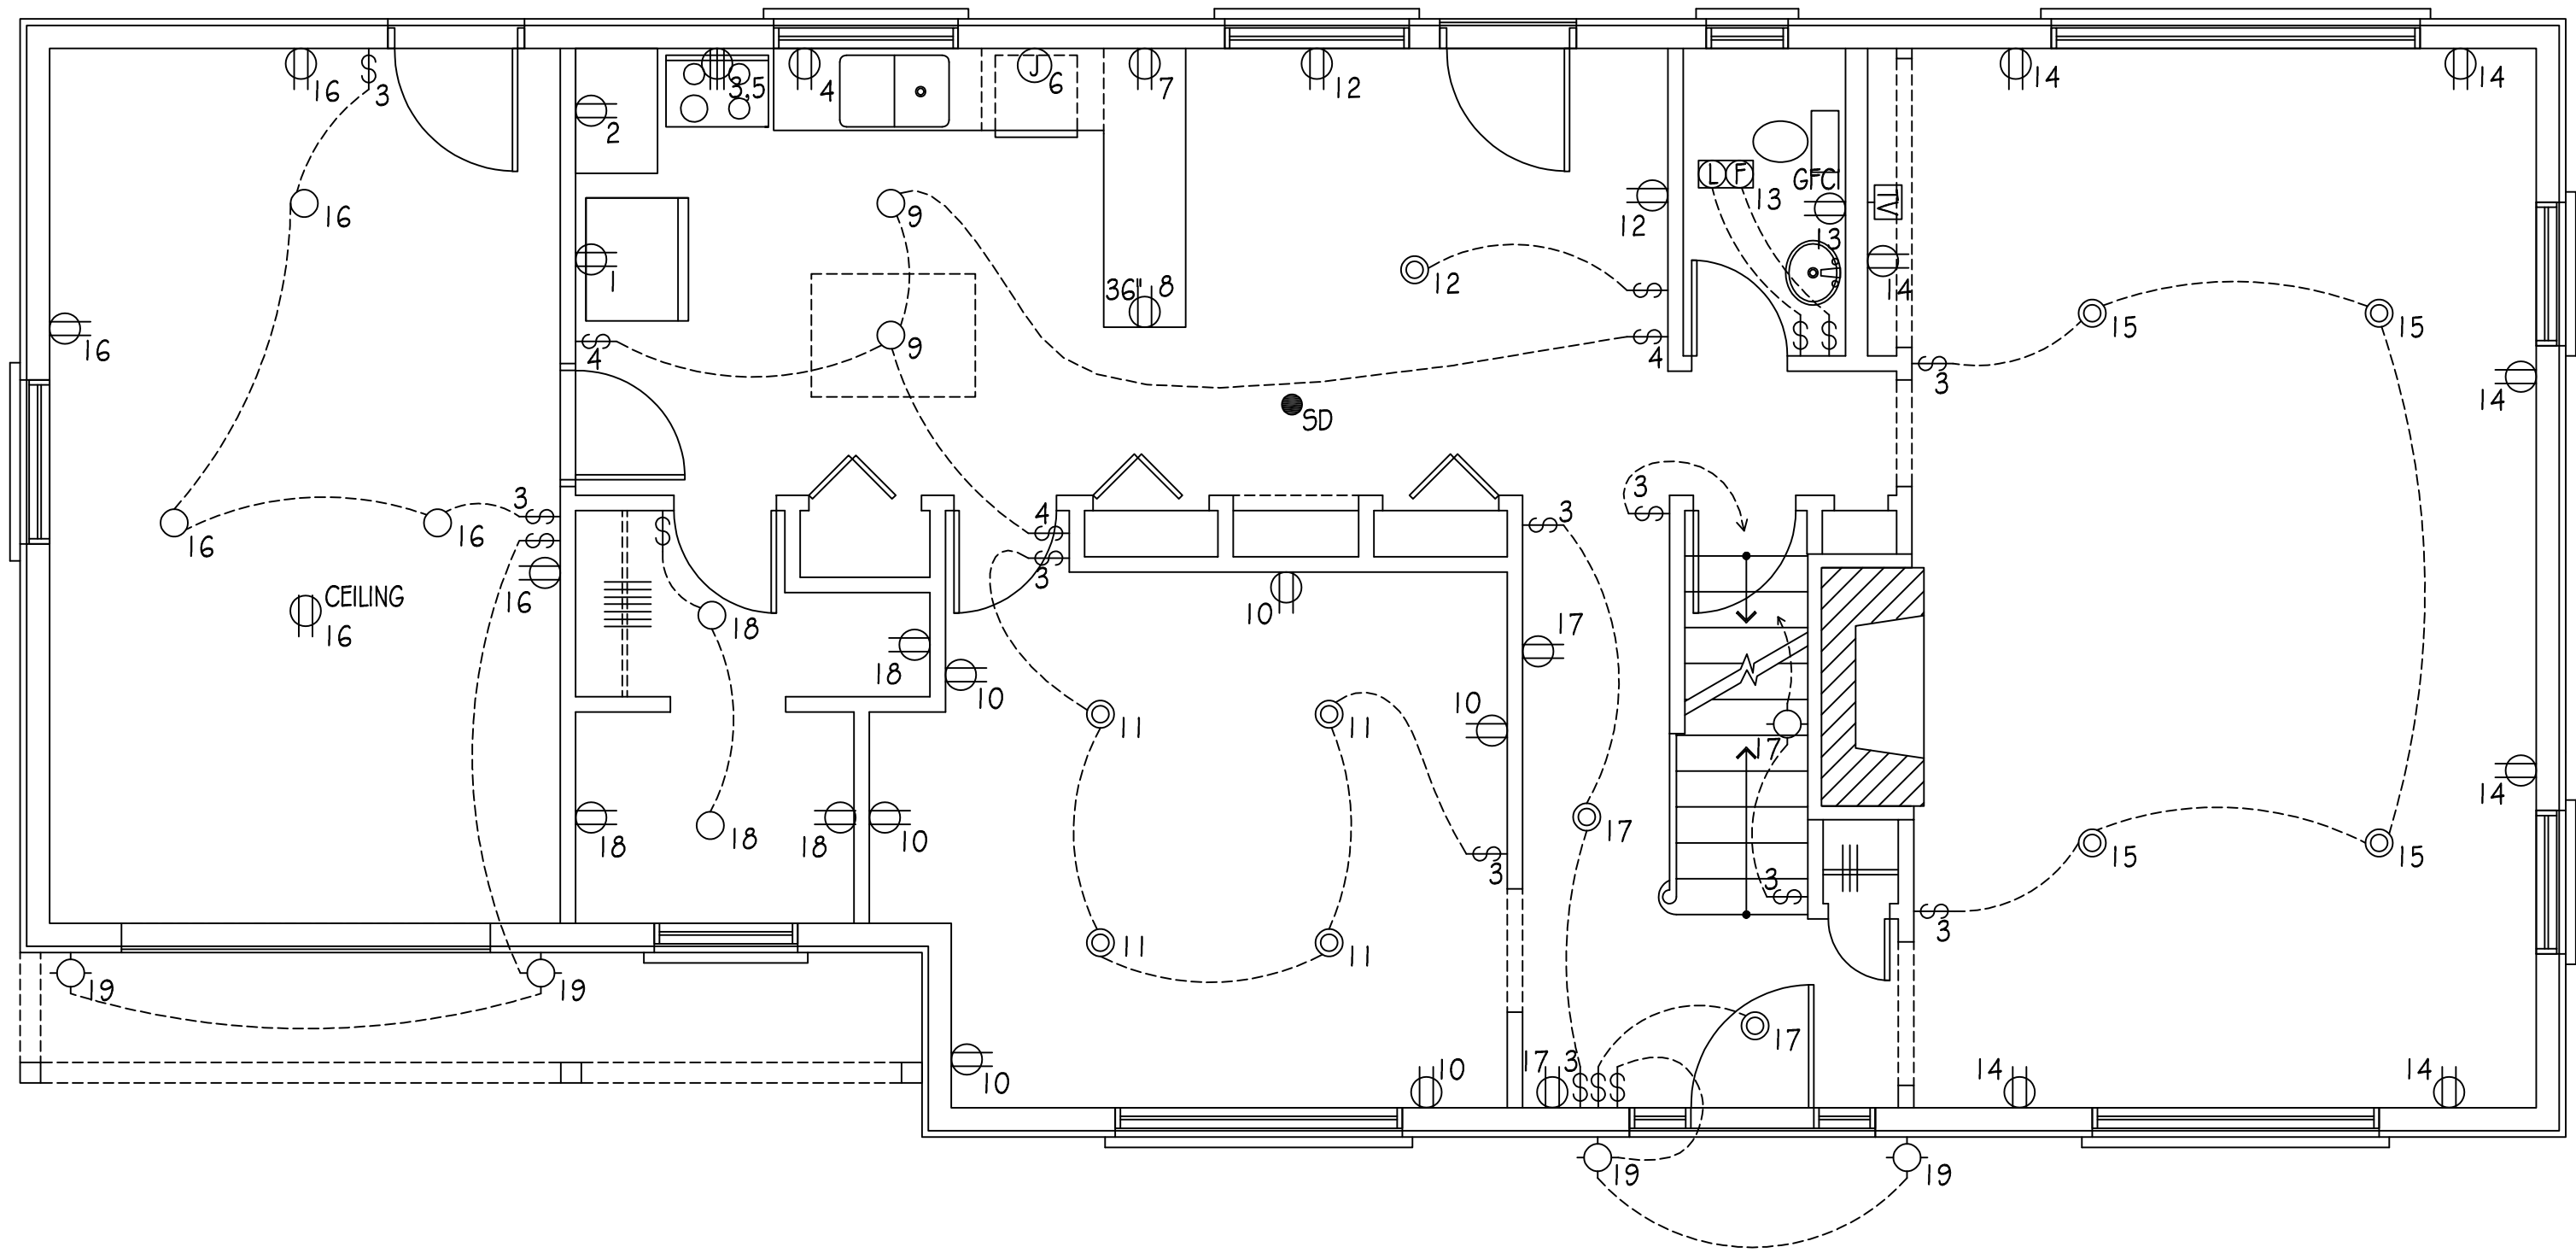

AUTODESK	OWNER VACC Verdun Adult and Career Centre	PROJECT RESIDENTIAL ELECTRICAL LAYOUT RESIDENTIAL AND COMMERCIAL DRAFTING-MODULE 04	REV.# #1	DRAWN BY NAWRAS	DATE 2022-09-07	DRAWING NAME E-FIRST FLOOR PLAN	E-102
			REV.DATE 2022-09-07	VERIFIED BY NIGEL	DRAWING SCALE 1/4"=1'-0"	FILE NAME M19_A04_NAWRAS.dwg	